


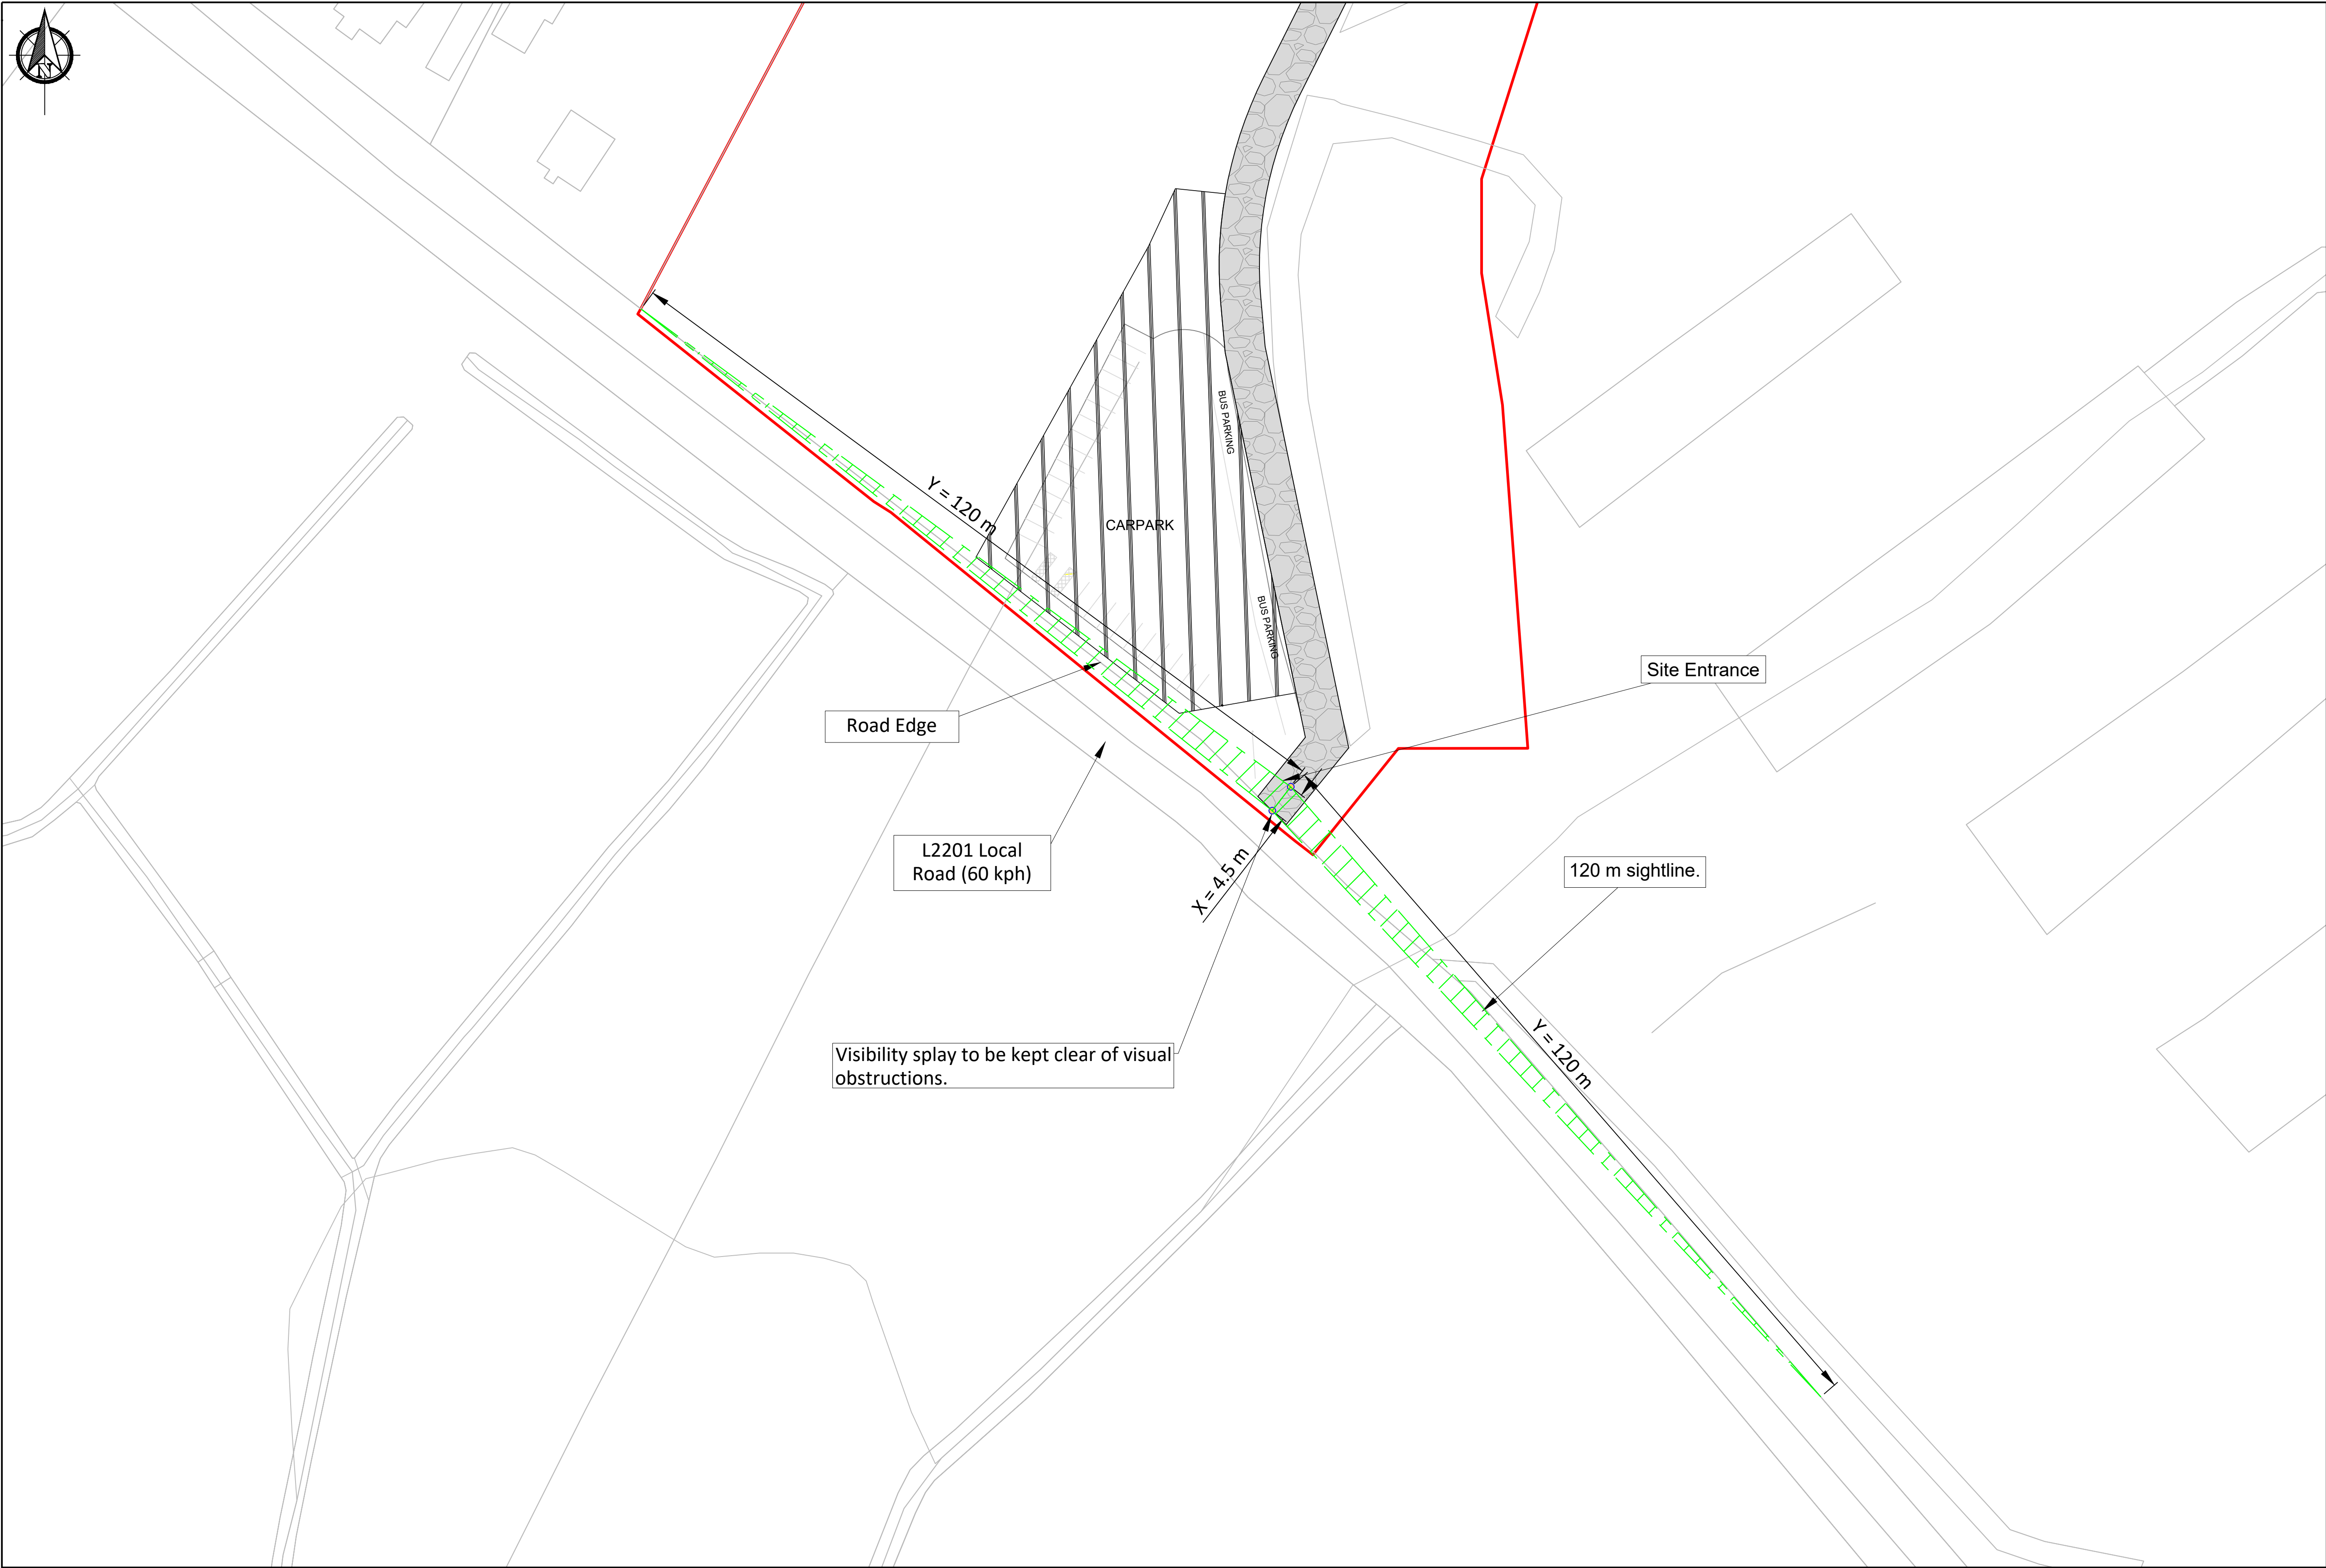

- Legend**
- Planning Boundary
 - Access Track
 - Sight Line & Visibility Splay
 - Existing Recreational Amenity Car Park
 - Proposed Recreational Amenity Car Park
 - Security Building

Notes.


- This drawing is for planning purposes only.
- Dimensions in meters unless otherwise noted.
- Levels shown relative to ordnance datum (Malin Head).
- Co-ordinates are to Irish Transverse Mercator (ITM).

Note:
All coordinates are in ITM.
Refer to 1:1000 scale site layout maps for proposed infrastructure finished levels.

See BEMP for details of proposed biodiversity enhancement measures.

Drainage not shown. Refer out to drainage drawings:
Refer to Drainage Layout drawings P1617-1-0226-A1-D101 to P1617-1-0226-A1-D112 prepared by Hydro Environmental Services.

No visual obstructions will interfere within proposed sightlines.

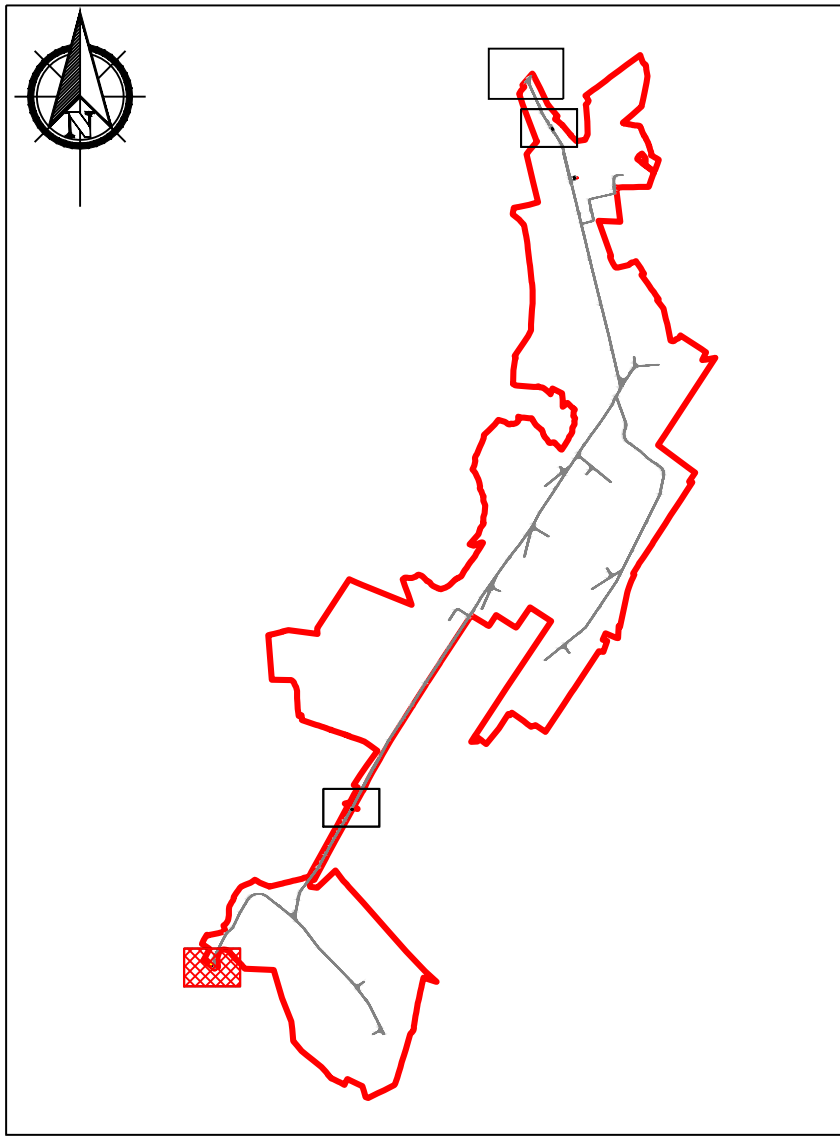

If Applicable : Ordnance Survey Ireland Licence No. CYAL50221678 © Ordnance Survey Ireland and Government of Ireland
OSI 4578, 4579, 4580, 4637, 4638, 4639, 4697, 4698, 4699, 4758, 4759, 4760, 4818, 4819, 4820, 4881, 4882, 4883



No part of this document may be reproduced or transmitted in any form or stored in any retrieval system of any nature without the written permission of Fehily Timoney & Company as copyright holder except as agreed for use on the project for which the document was originally issued. Do not scale. Use figured dimensions only. If in doubt - Ask!

Rev.	Description	App By	Date
P01	ISSUE FOR PLANNING		

PROJECT		CLIENT				
LITTLETON WIND FARM		LITTLETON WIND FARM DAC				
SHEET	SITE ENTRANCE 1 LAYOUT PLAN	Date	30.04.26	Project number	P20-211	Scale (@ A1)
		As Shown				
		Drawn by	EB	Drawing Number		Rev
		Checked by	TB	P20-211-0101-0001		P01
(Sheet not robust Q101)						

O:\ACAD\2020\P20-211\P20-211-0101-0001

14 May 2026 (O:\ACAD\2020\P20-211\P20-211-0101-0001)