


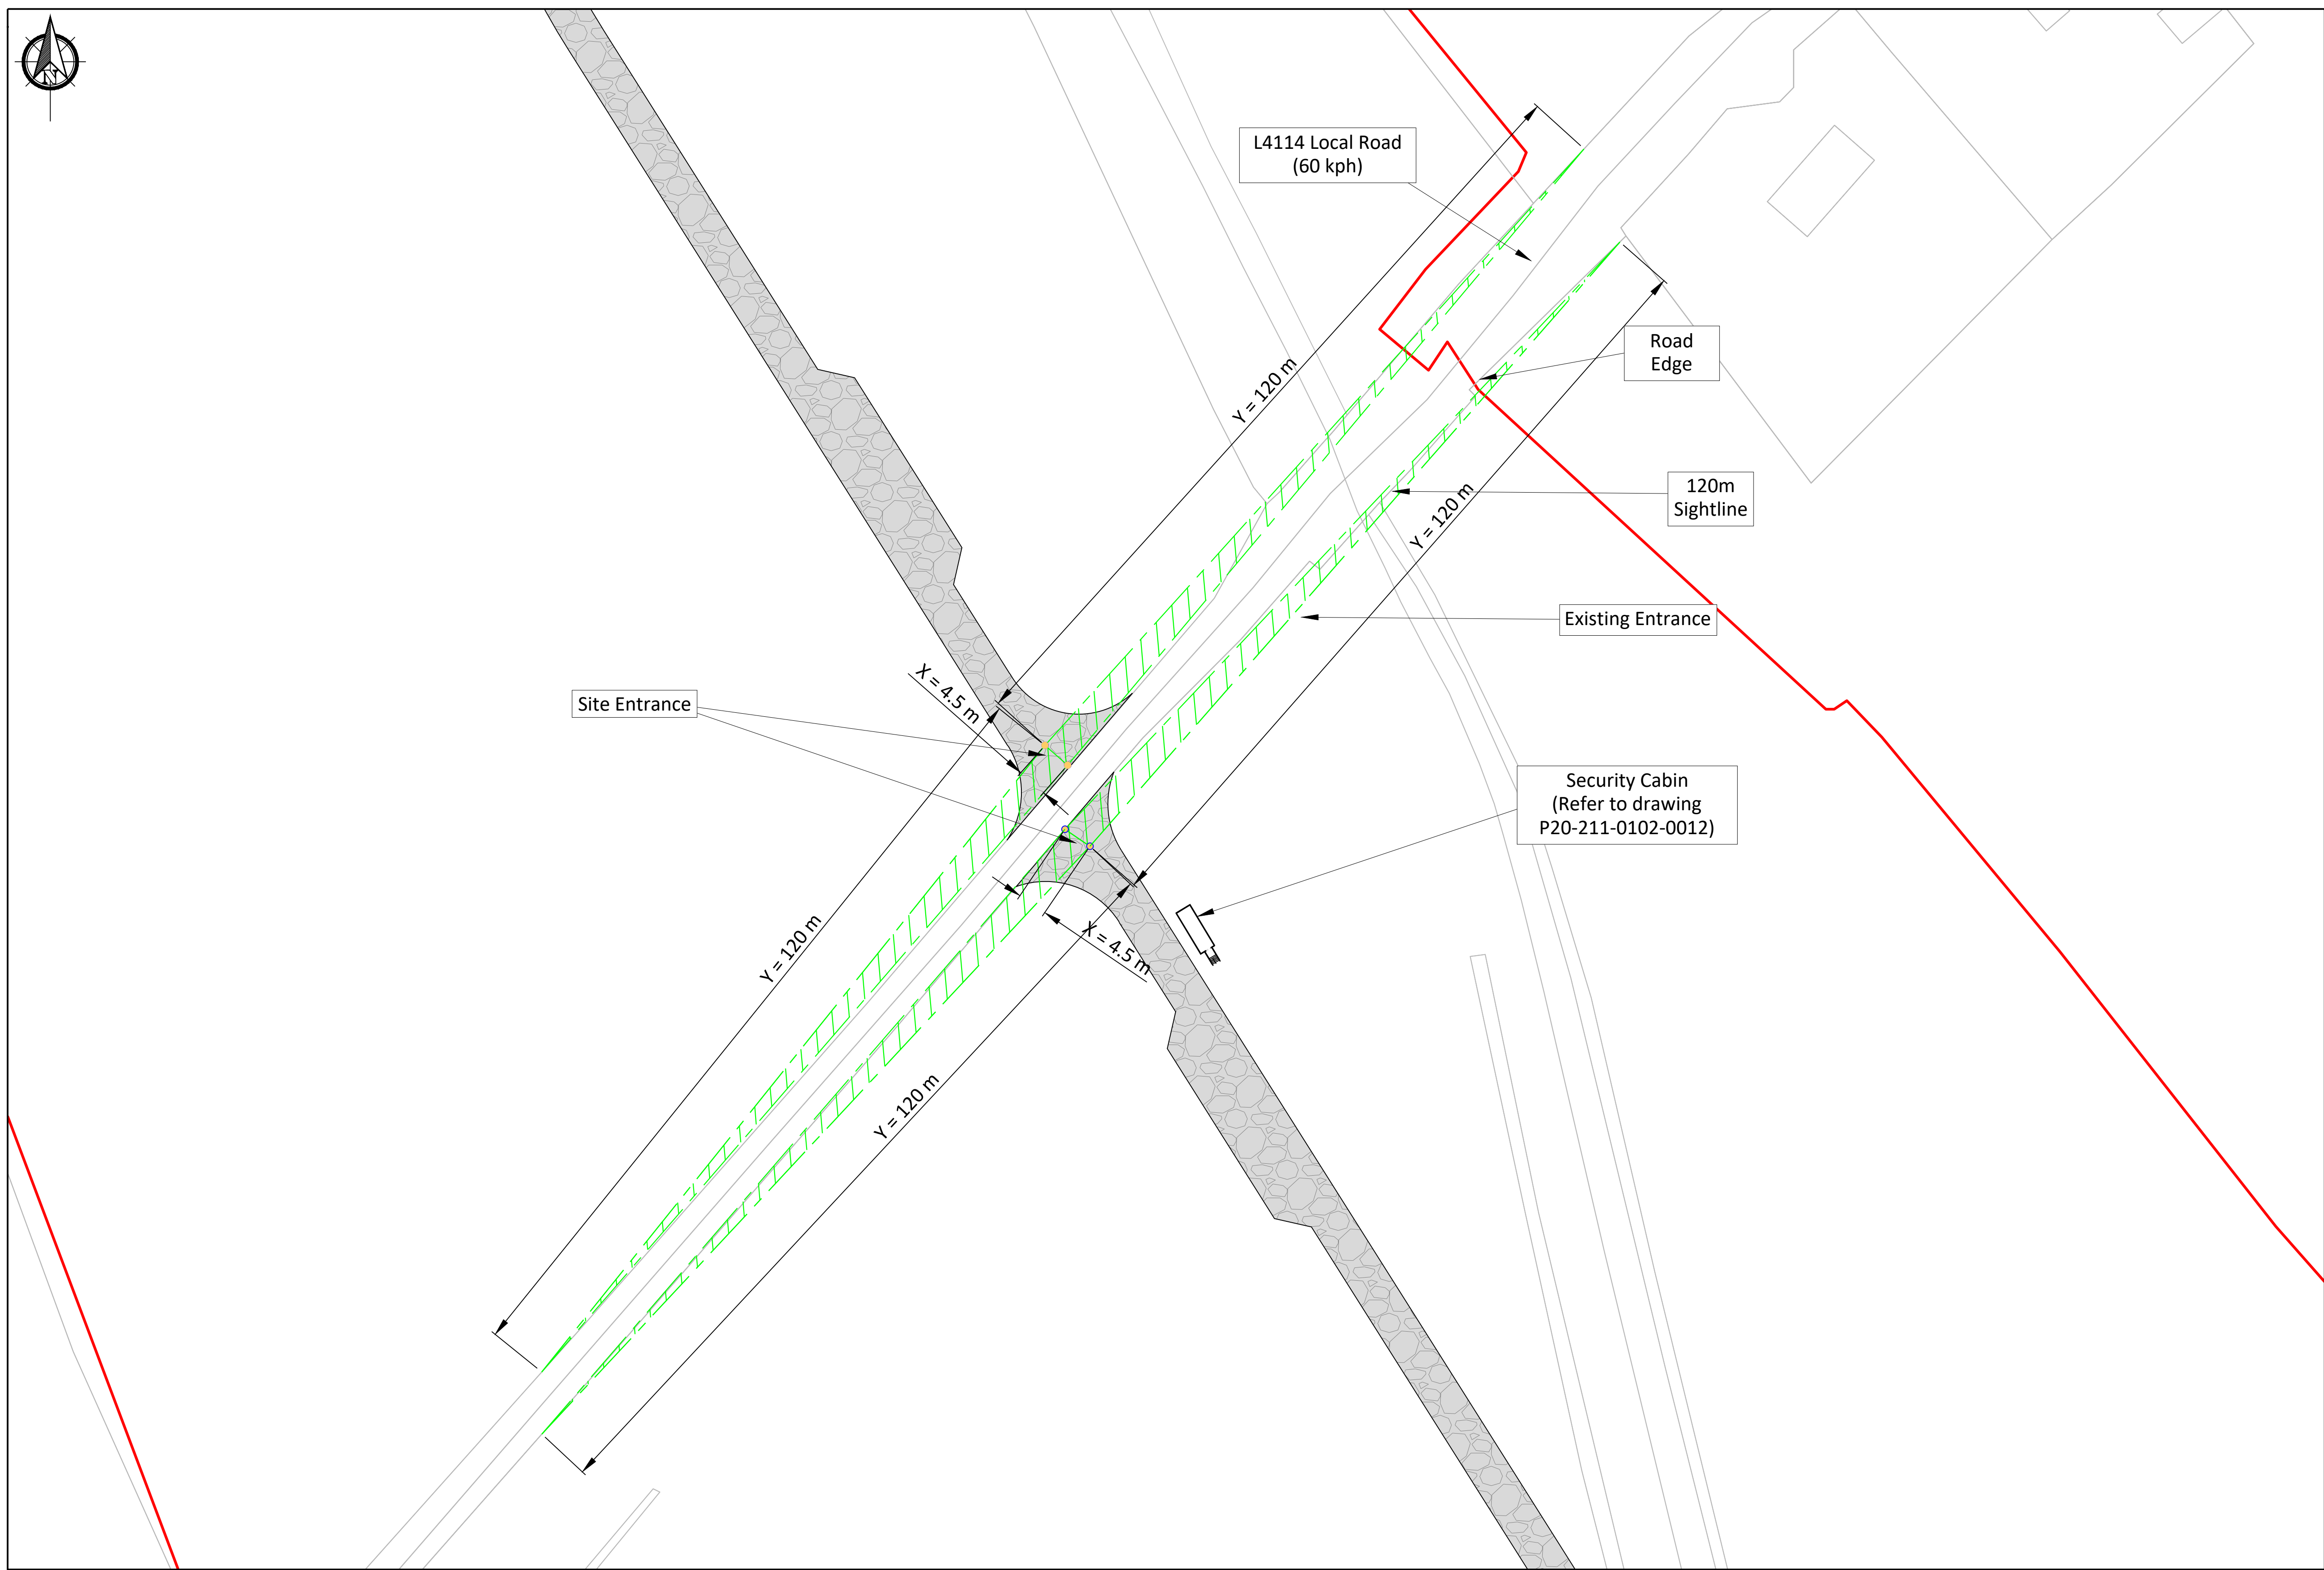

- Legend**
- Planning Boundary
 - Access Track
 - Sight Line & Visibility Splay
 - Existing Recreational Amenity Car Park
 - Proposed Recreational Amenity Car Park
 - Security Building

Notes.


- This drawing is for planning purposes only.
- Dimensions in meters unless otherwise noted.
- Levels shown relative to ordnance datum (Malin Head).
- Co-ordinates are to Irish Transverse Mercator (ITM).

Note:
All coordinates are in ITM.
Refer to 1:1000 scale site layout maps for proposed infrastructure finished levels.

See BEMP for details of proposed biodiversity enhancement measures.

Drainage not shown. Refer out to drainage drawings:
Refer to Drainage Layout drawings P1617-1-0226-A1-D101 to P1617-1-0226-A1-D112 prepared by Hydro Environmental Services.

No visual obstructions will interfere within proposed sightlines.

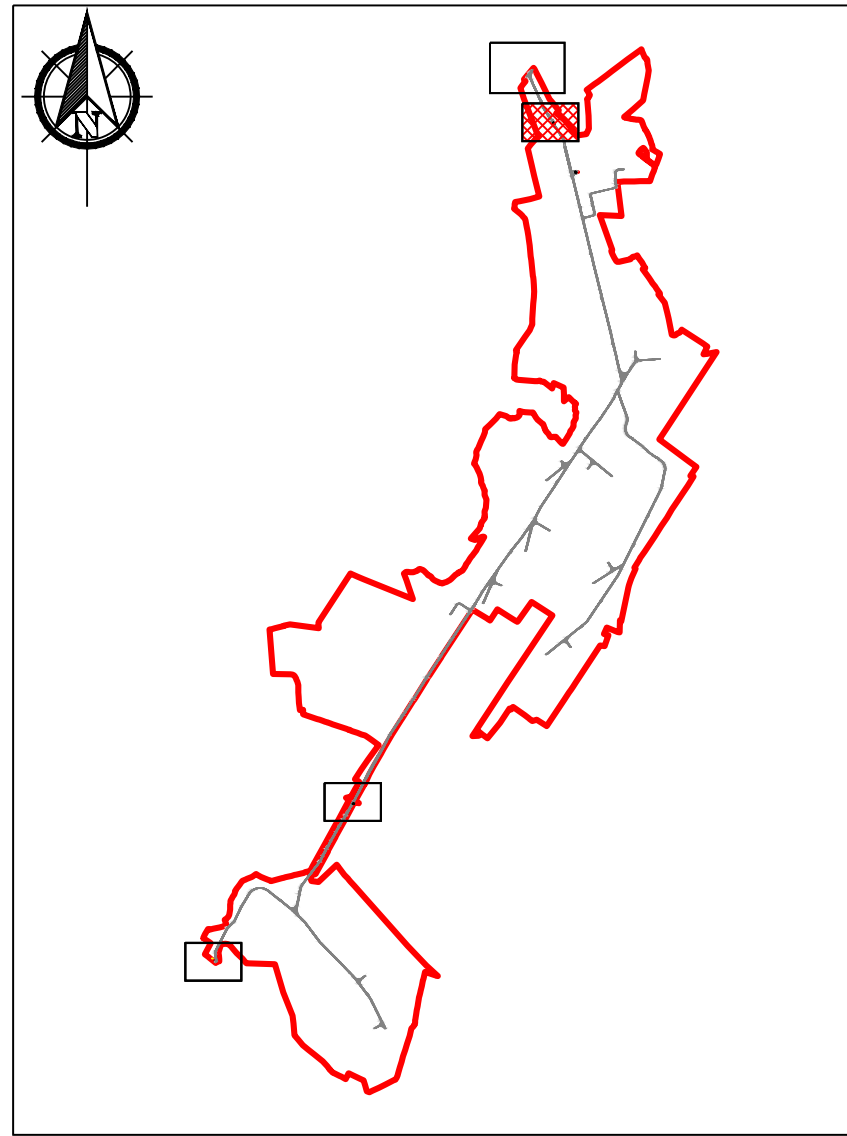

PLAN

1:500

3

0m 4m 8m 12m 16m 20m 24m 28m 32m 36m 40m

Scale 1:500

If Applicable : Ordnance Survey Ireland Licence No. CYAL50221678 © Ordnance Survey Ireland and Government of Ireland
OSI 4578, 4579, 4580, 4637, 4638, 4639, 4697, 4698, 4699, 4758, 4759, 4760, 4818, 4819, 4820, 4881, 4882, 4883

Rev.	Description	App By	Date
P01	ISSUE FOR PLANNING		

PROJECT	LITTLETON WIND FARM		CLIENT			LITTLETON WIND FARM DAC	
	SITE ENTRANCE 4/5 LAYOUT PLAN		Date	30.04.26	Project number	P20-211	Scale (@ A1) As Shown
SHEET			Drawn by	EB	Drawing Number		Rev
			Checked by	TB	P20-211-0101-0003		P01
			(Sheet not robust 0101)				