


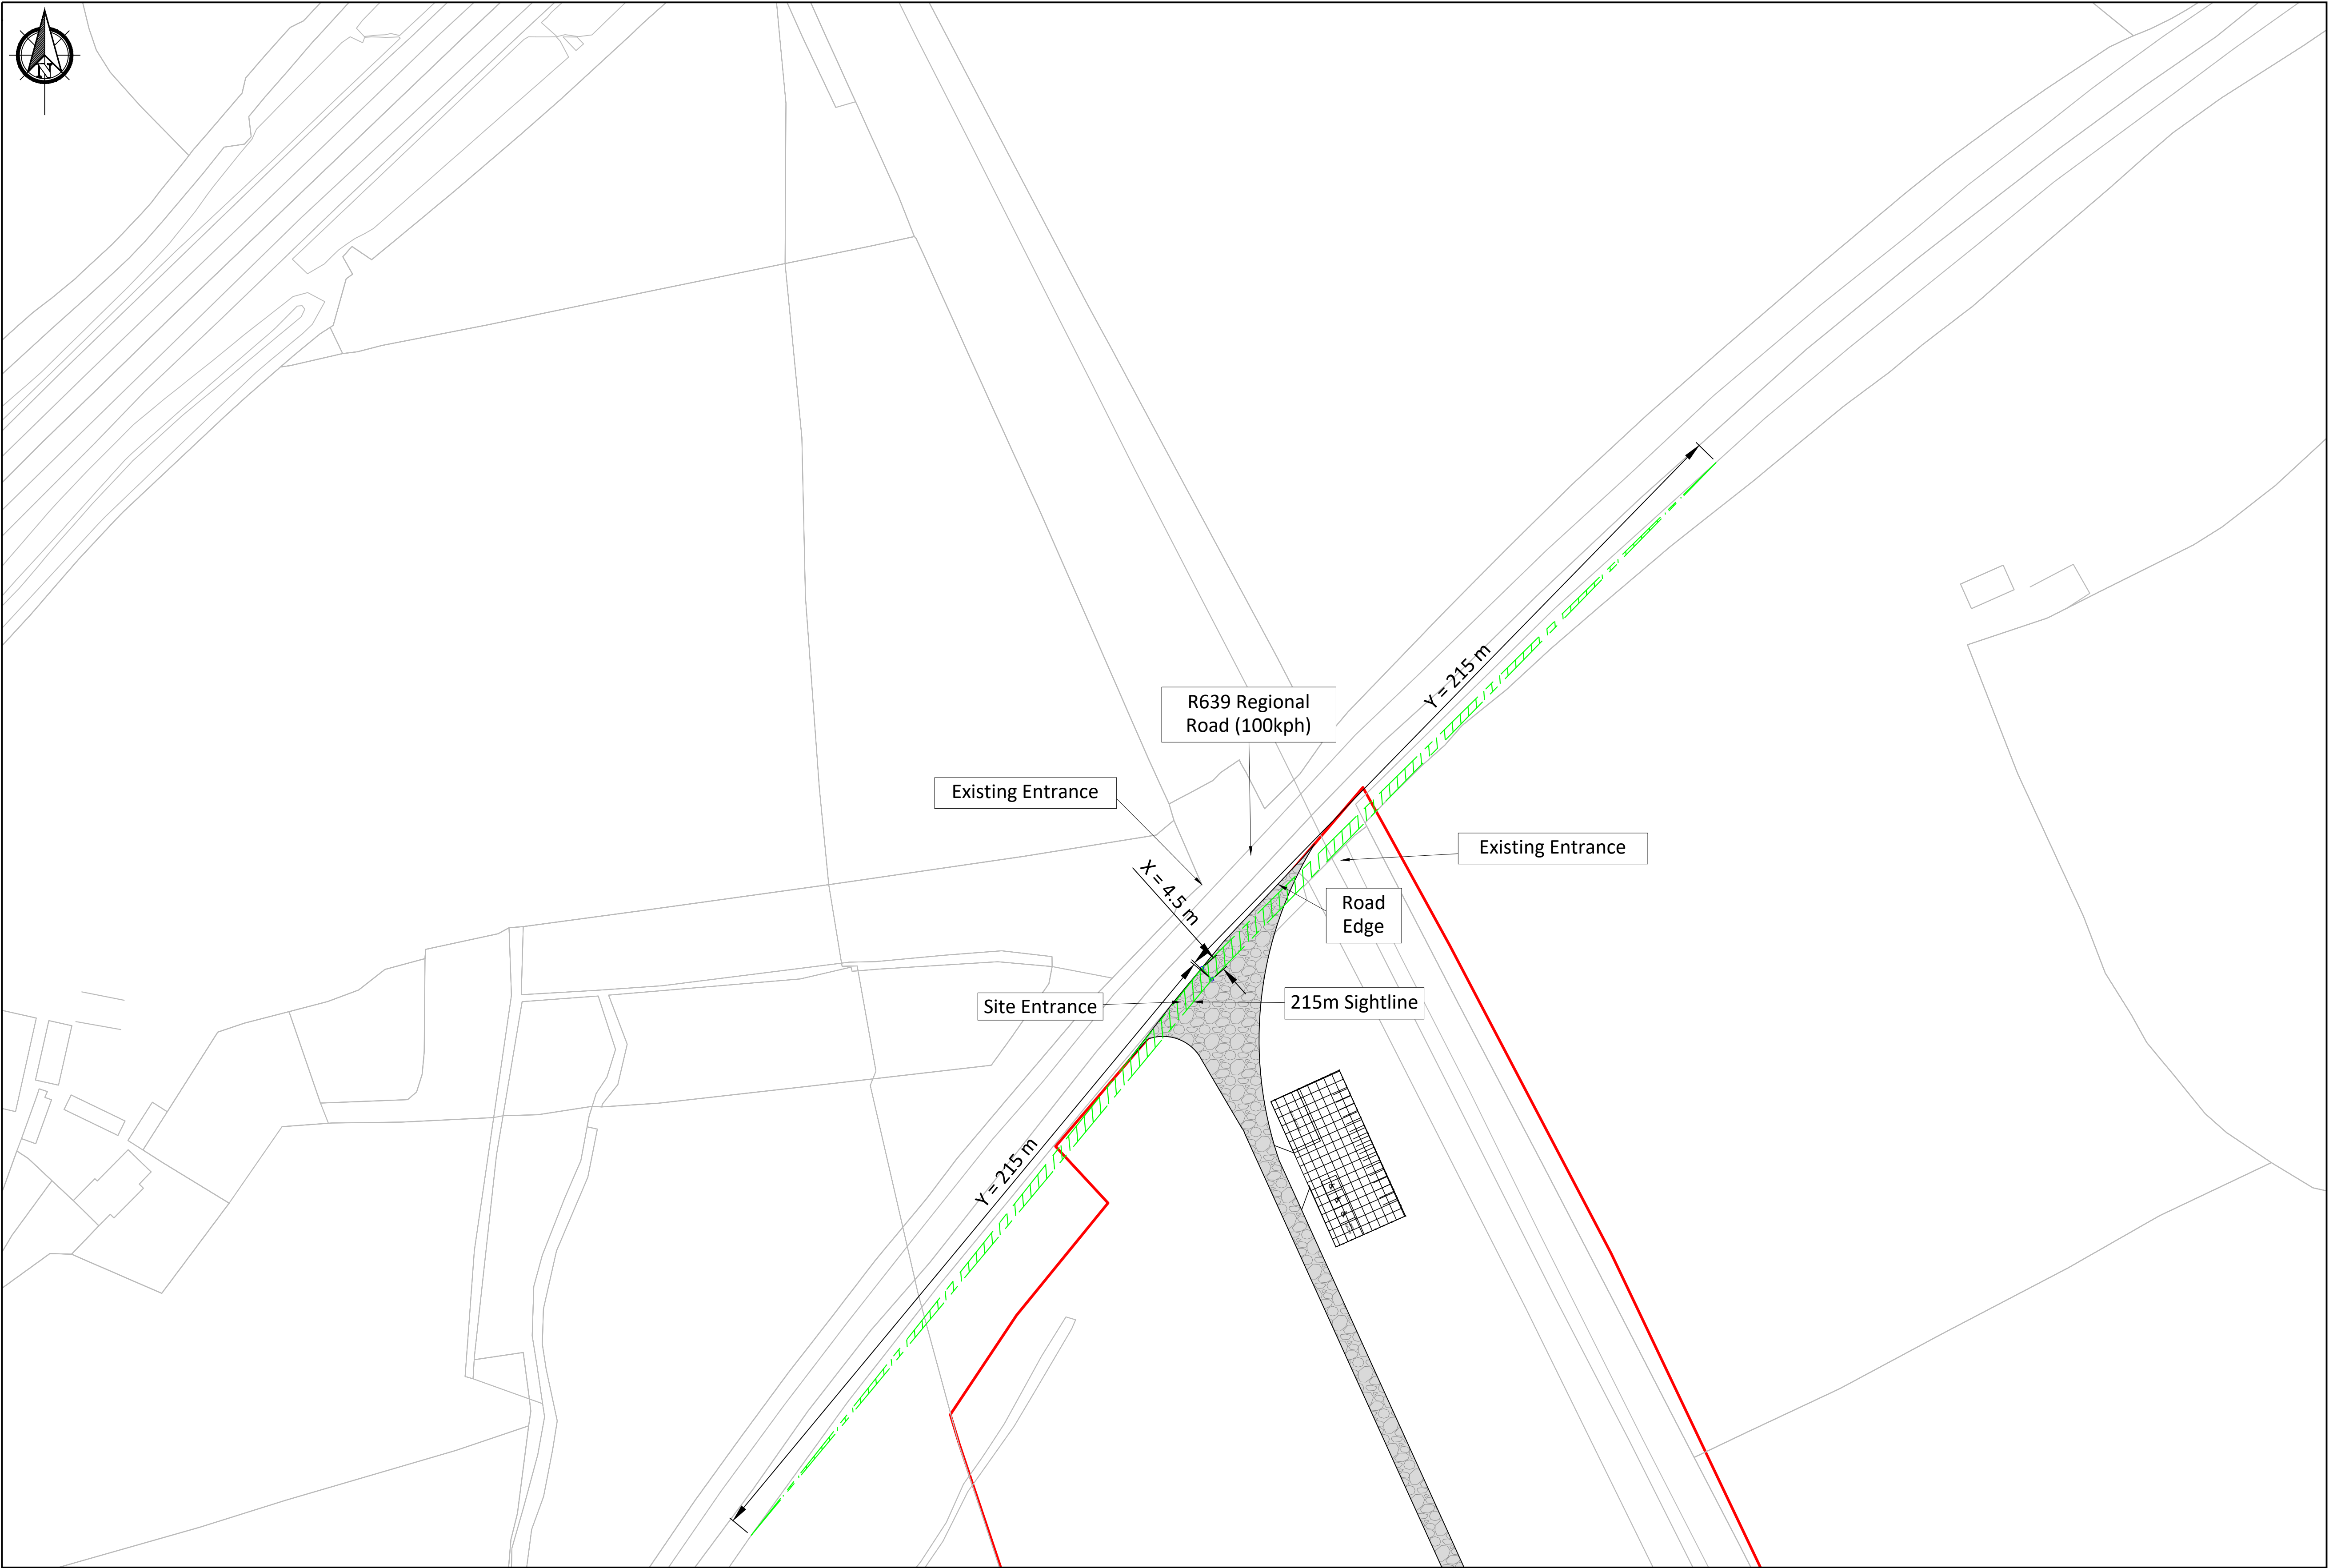

- Legend**
- Planning Boundary
 - Access Track
 - Sight Line & Visibility Splay
 - Existing Recreational Amenity Car Park
 - Proposed Recreational Amenity Car Park
 - Security Building

Notes.


1. This drawing is for planning purposes only.
2. Dimensions in meters unless otherwise noted.
3. Levels shown relative to ordnance datum (Malin Head).
4. Co-ordinates are to Irish Transverse Mercator (ITM).

Note:
All coordinates are in ITM.
Refer to 1:1000 scale site layout maps for proposed infrastructure finished levels.

See BEMP for details of proposed biodiversity enhancement measures.

Drainage not shown. Refer out to drainage drawings:
Refer to Drainage Layout drawings P1617-1-0226-A1-D101 to P1617-1-0226-A1-D112 prepared by Hydro Environmental Services.

No visual obstructions will interfere within proposed sightlines.

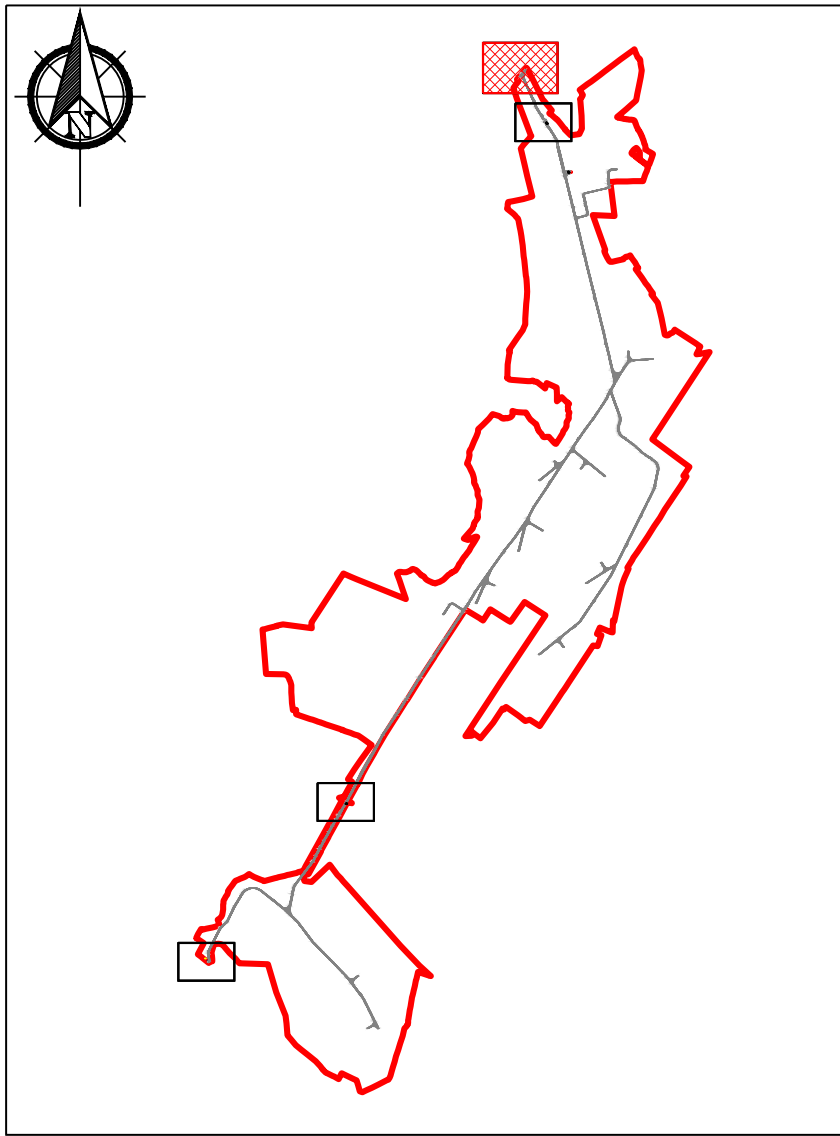

PLAN

1:1000

4

0m 8m 16m 24m 32m 40m 48m 56m 64m 72m 80m

Scale 1:1000

If Applicable : Ordnance Survey Ireland Licence No. CYAL50221678 © Ordnance Survey Ireland and Government of Ireland
OSI 4578, 4579, 4580, 4637, 4638, 4639, 4697, 4698, 4699, 4758, 4759, 4760, 4818, 4819, 4820, 4881, 4882, 4883



**FEHILY
TIMONEY**

Cork | Dublin | Carlow

www.fehilytimoney.ie

No part of this document may be reproduced or transmitted in any form or stored in any retrieval system of any nature without the written permission of Fehily Timoney & Company as copyright holder except as agreed for use on the project for which the document was originally issued. Do not scale. Use figured dimensions only. If in doubt - Ask!

Rev.	Description	App By	Date
P01	ISSUE FOR PLANNING		

PROJECT	LITTLETON WIND FARM		CLIENT				LITTLETON WIND FARM DAC		
SHEET	SITE ENTRANCE 6 LAYOUT PLAN		Date	30.04.26	Project number	P20-211		Scale (@ A1)	As Shown
			Drawn by	EB	Drawing Number		Rev		
			Checked by	TB	P20-211-0101-0004		P01		
(Sheet not subject Q102)									

O:\ACAD\2020\P20-211\P20-211-0101-0004

14 May 2026 (O:\ACAD\2020\P20-211\P20-211-0101-0004)